


Figure 13.4

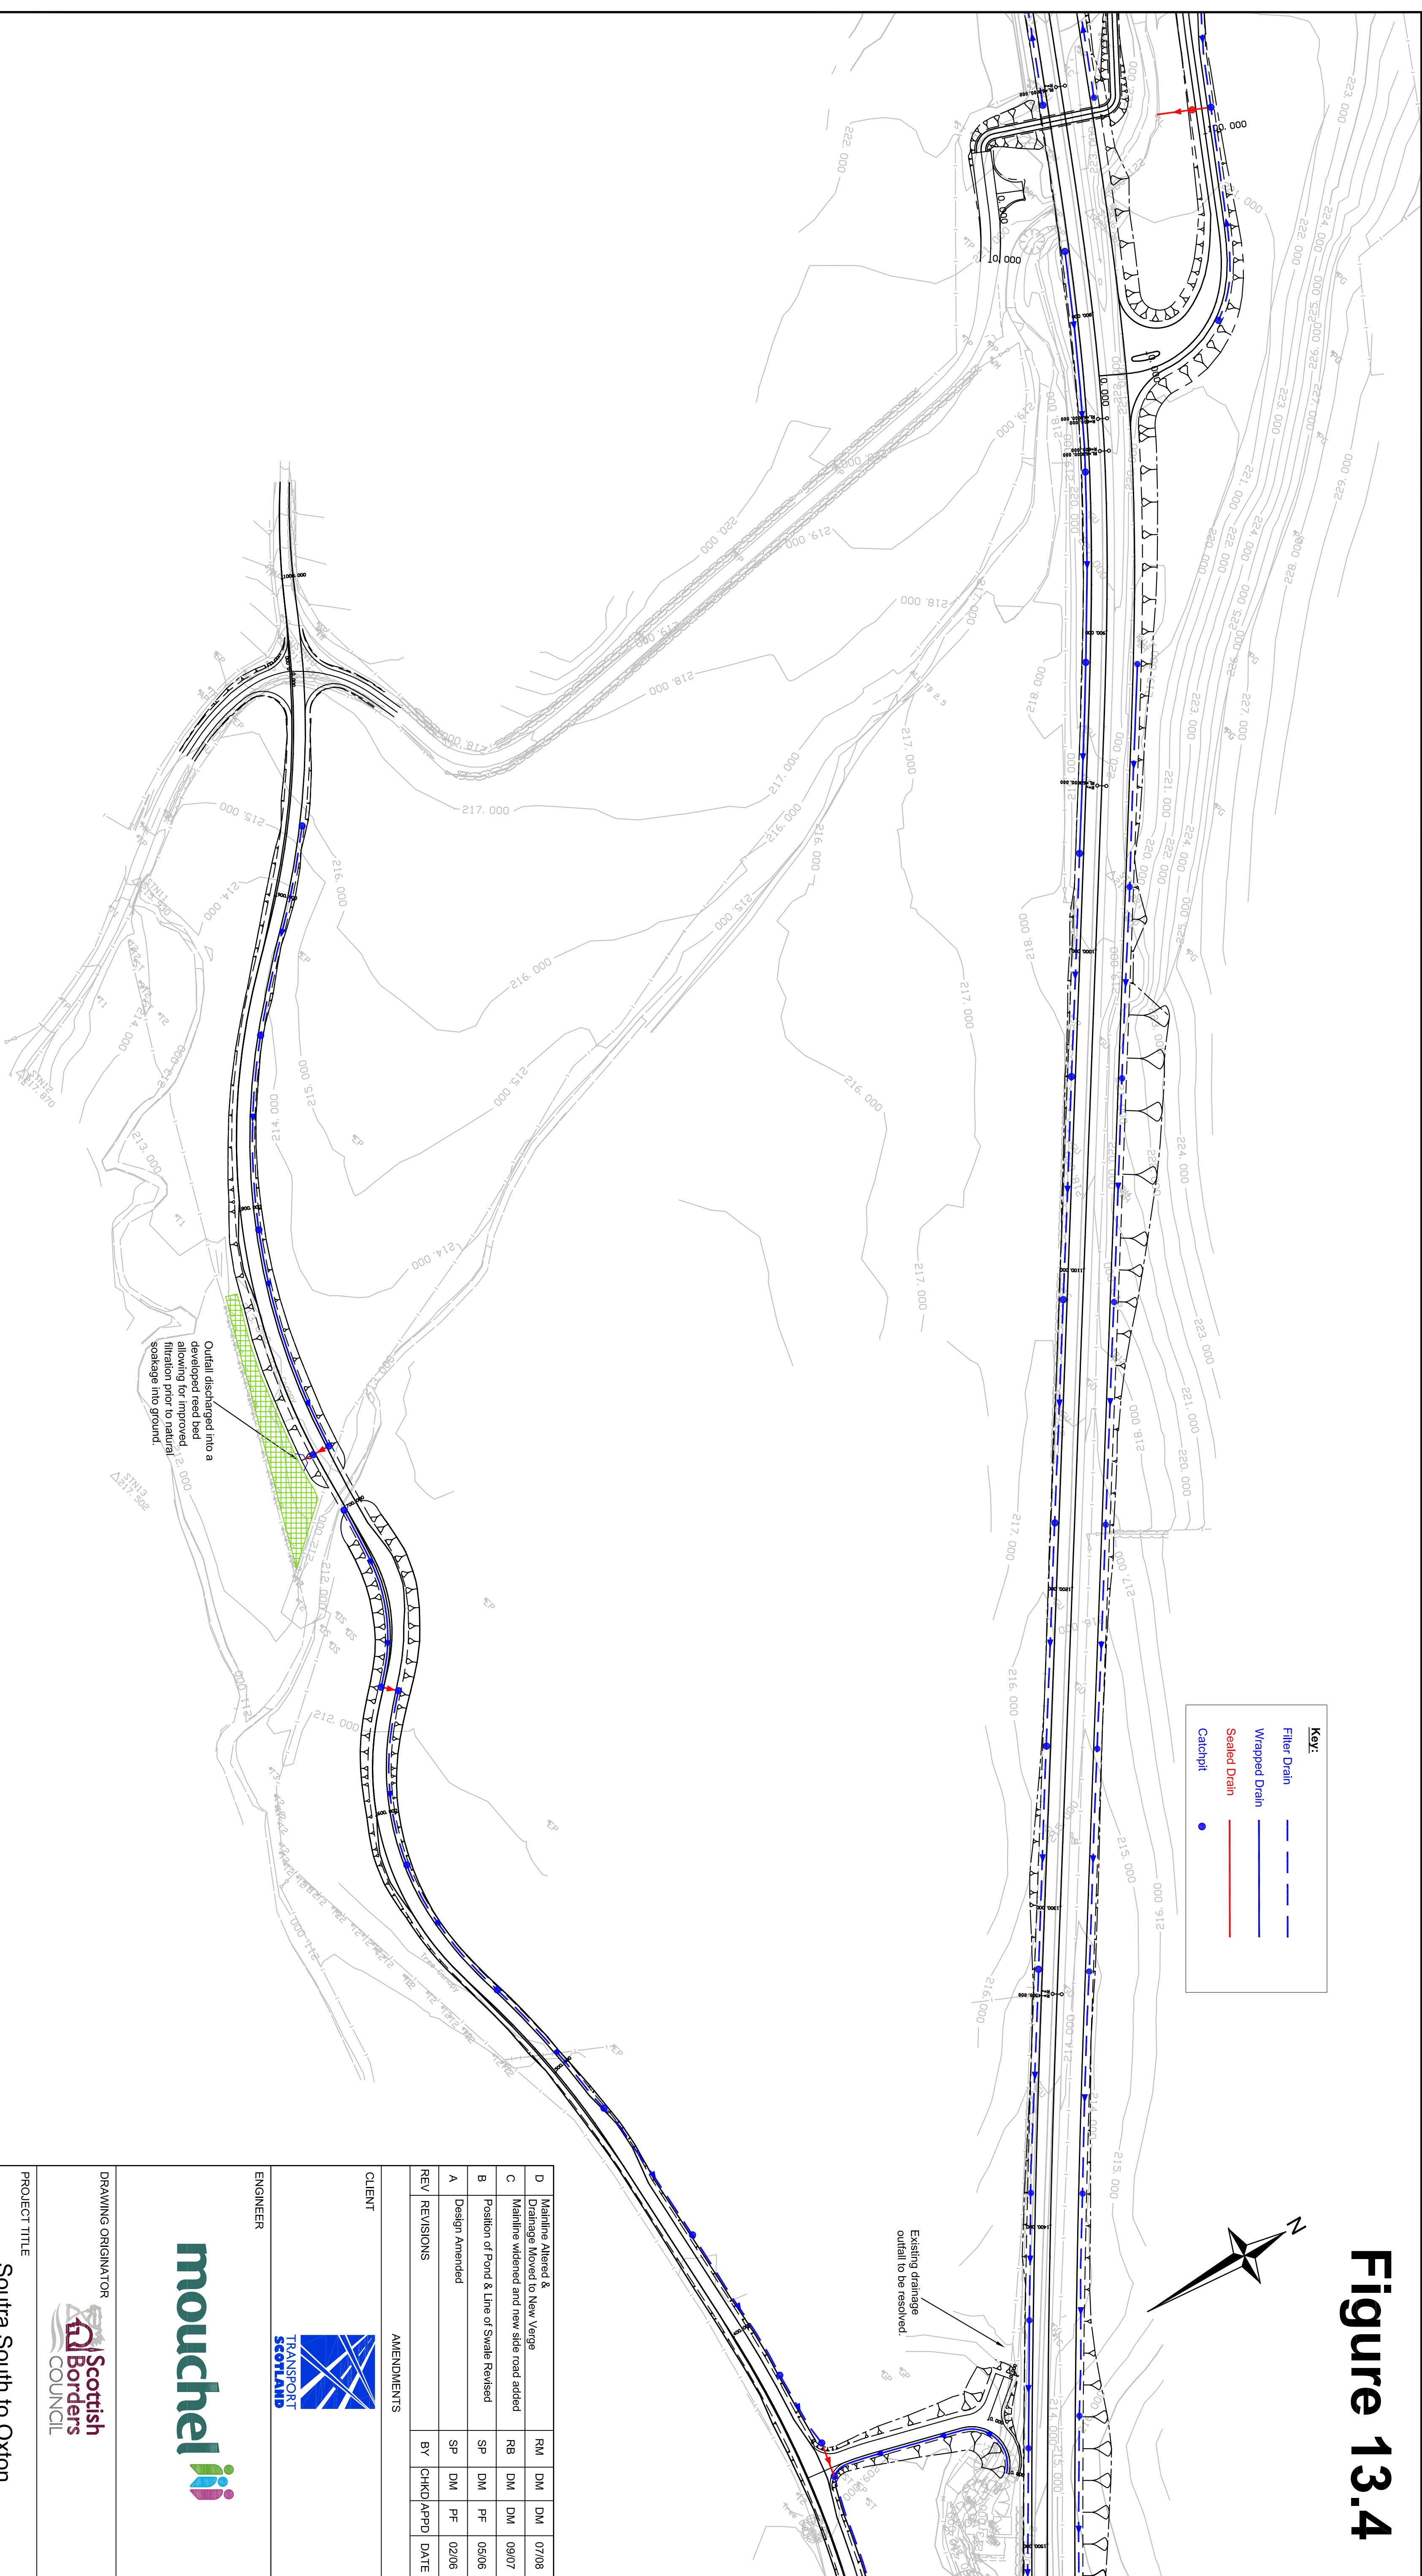

Key:

- Filler Drain
- Wrapped Drain
- Sealed Drain
- Catchpit

| REV | REVISIONS | BY | CHKD | APPD | DATE |
|-----|--|----|------|------|-------|
| D | Mainline Altered & Drainage Moved to New Verge | RM | DM | DM | 07/08 |
| C | Mainline widened and new side road added | RB | DM | DM | 09/07 |
| B | Position of Pond & Line of Swale Revised | SP | DM | PF | 05/06 |
| A | Design Amended | SP | DM | PF | 02/06 |

CLIENT

TRANSPORT SCOTLAND

ENGINEER

mouchel

Scottish Borders COUNCIL

PROJECT TITLE

Soutra South to Oxton Improvement Scheme

DRAWING TITLE

Preliminary Drainage Layout
(Sheet 2 of 3)

SCALE: A1 1:1000 A3 1:2000

| DESIGN BY: | CHECKED BY: | DATE: |
|-------------|--------------|-------|
| P Frankland | D Murphy | 01/08 |
| DRAWN BY: | APPROVED BY: | DATE: |
| P Giggor | P Frankland | 01/08 |

| PROJECT NUMBER | DRAWING NUMBER | REV |
|----------------|----------------|-----|
| DS03_114 | 151 | D |